


PLAN VIEW: ROAD 'E'


SCALE: 1" = 50'

CURVE	RADIUS	LENGTH	TANGENT	CHORD BEARING	DELTA	
C212	150.00'	64.96'	33.00'	64.45'	N79°03'23"E	24.48-42'

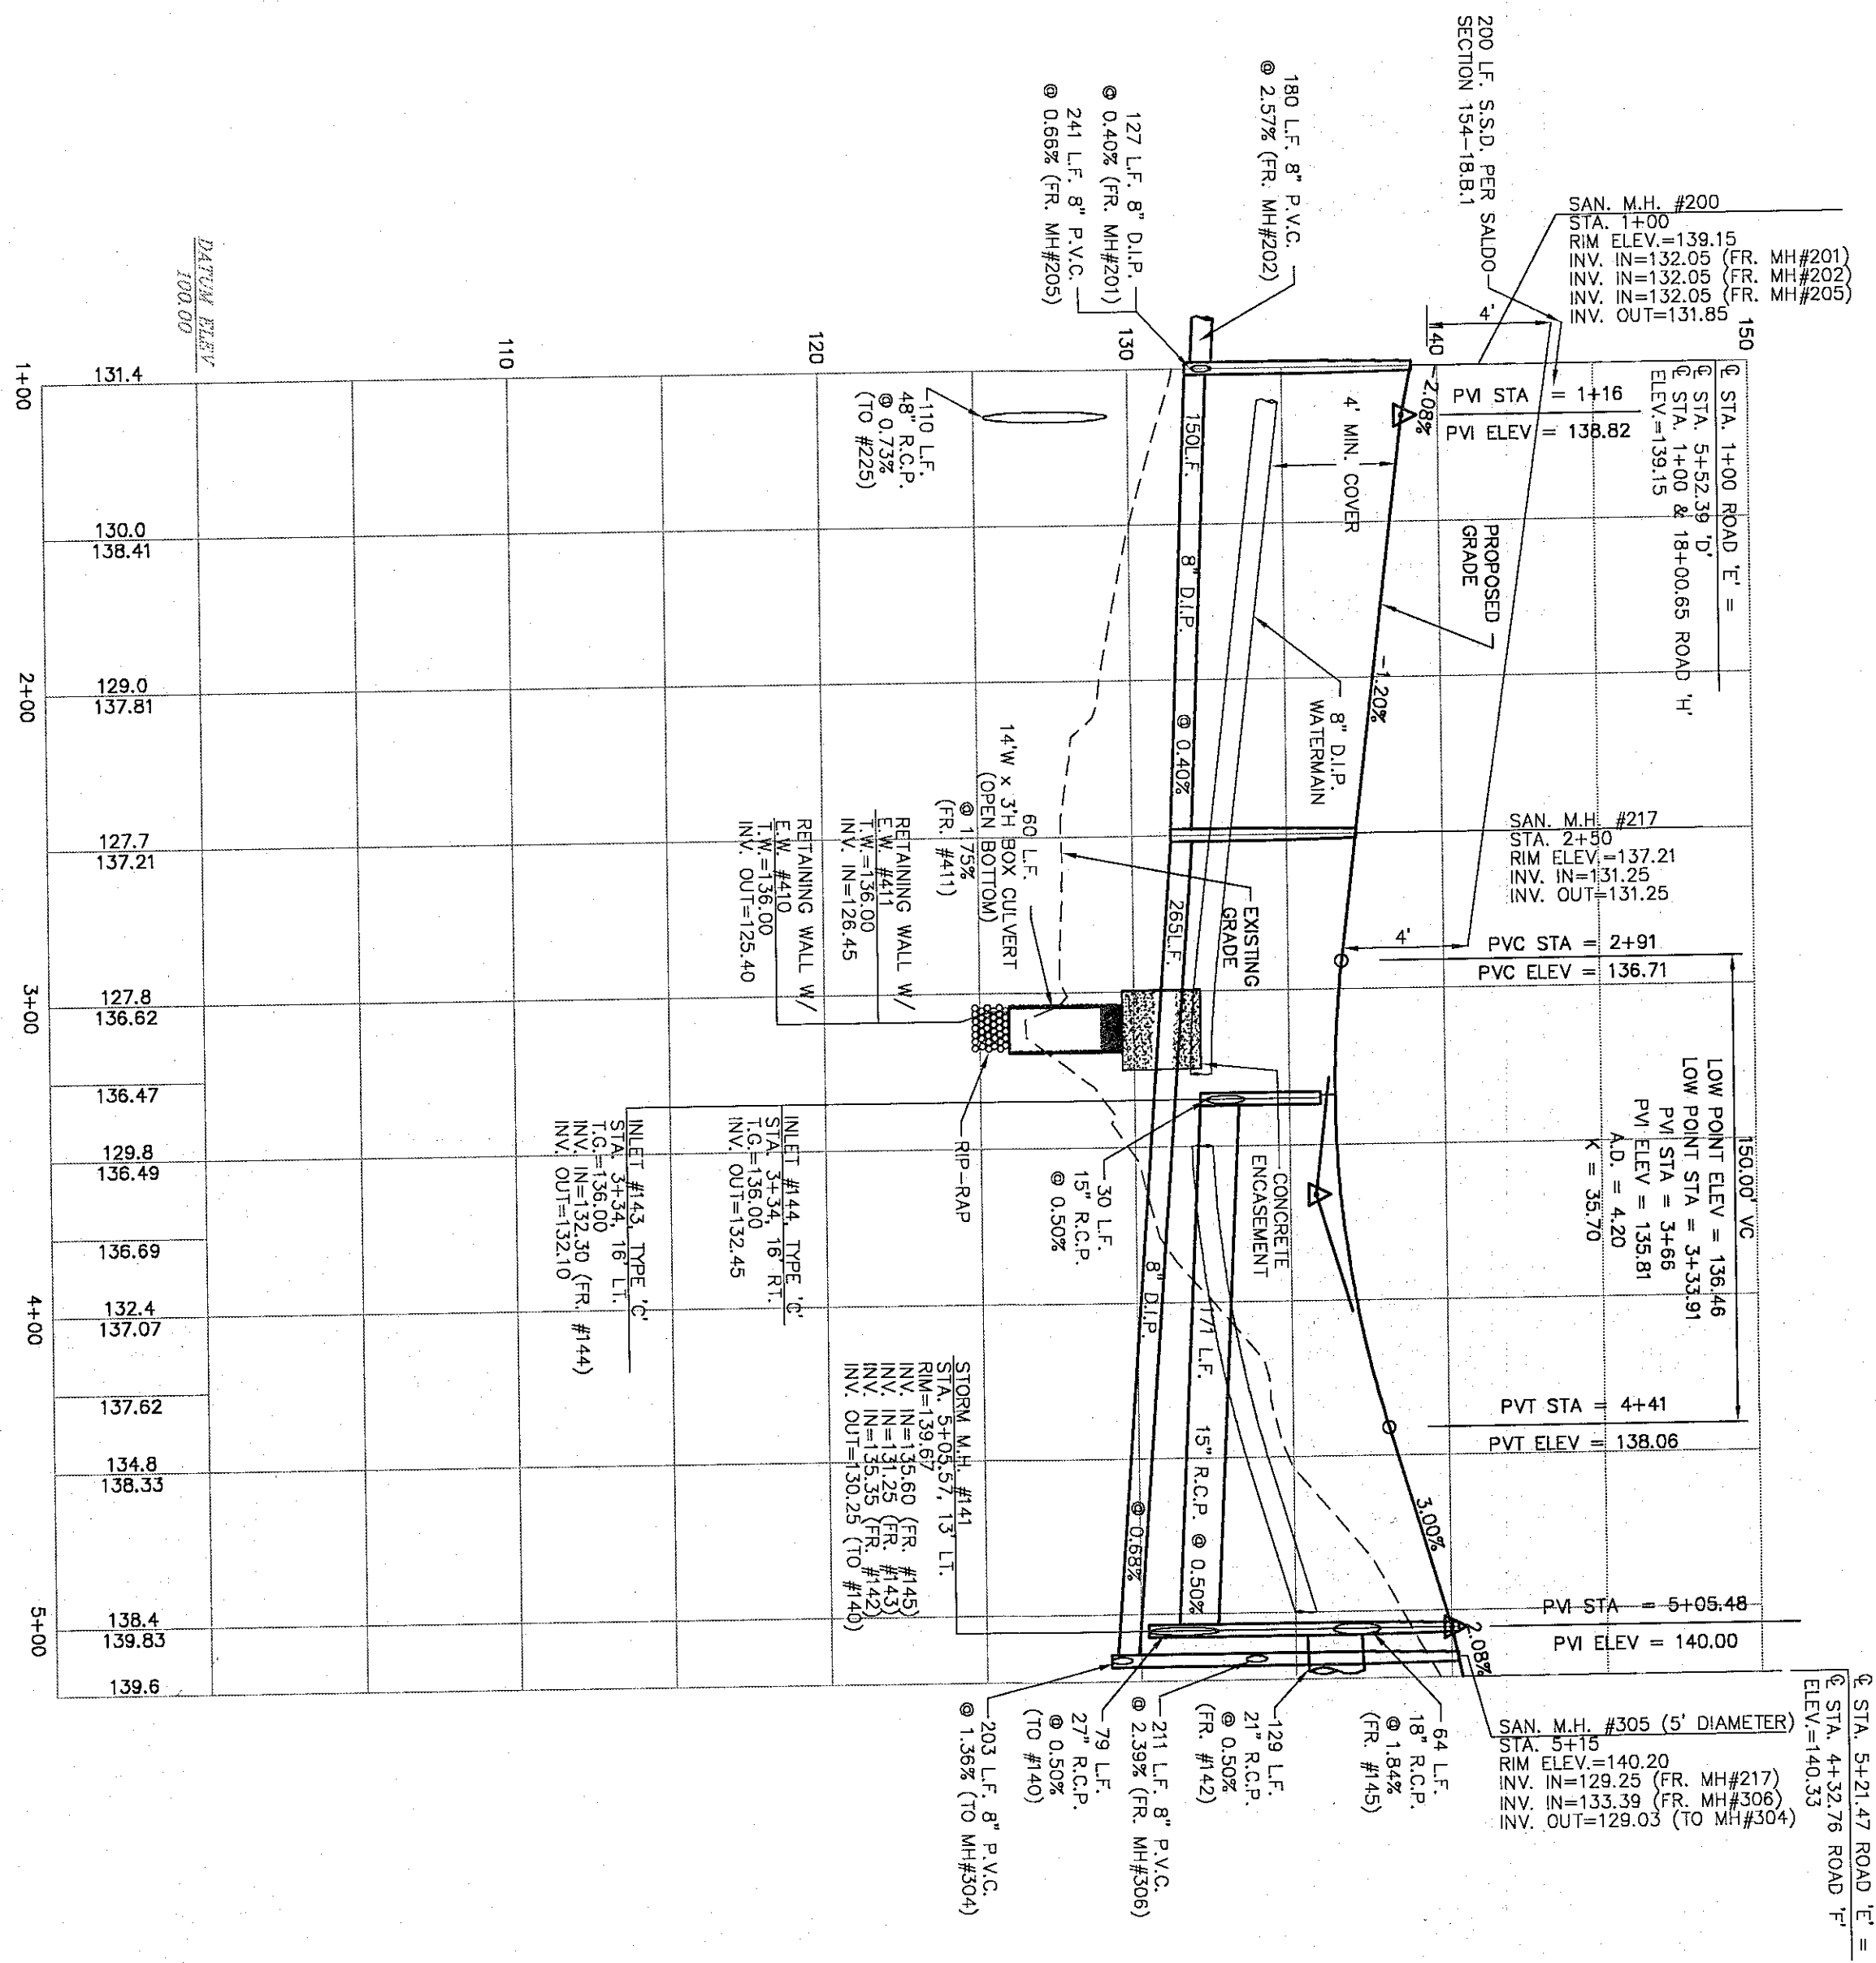


PROFILE: ROAD 'E'

SCALE: 1" = 50' HORIZ.
1" = 5' VERT.

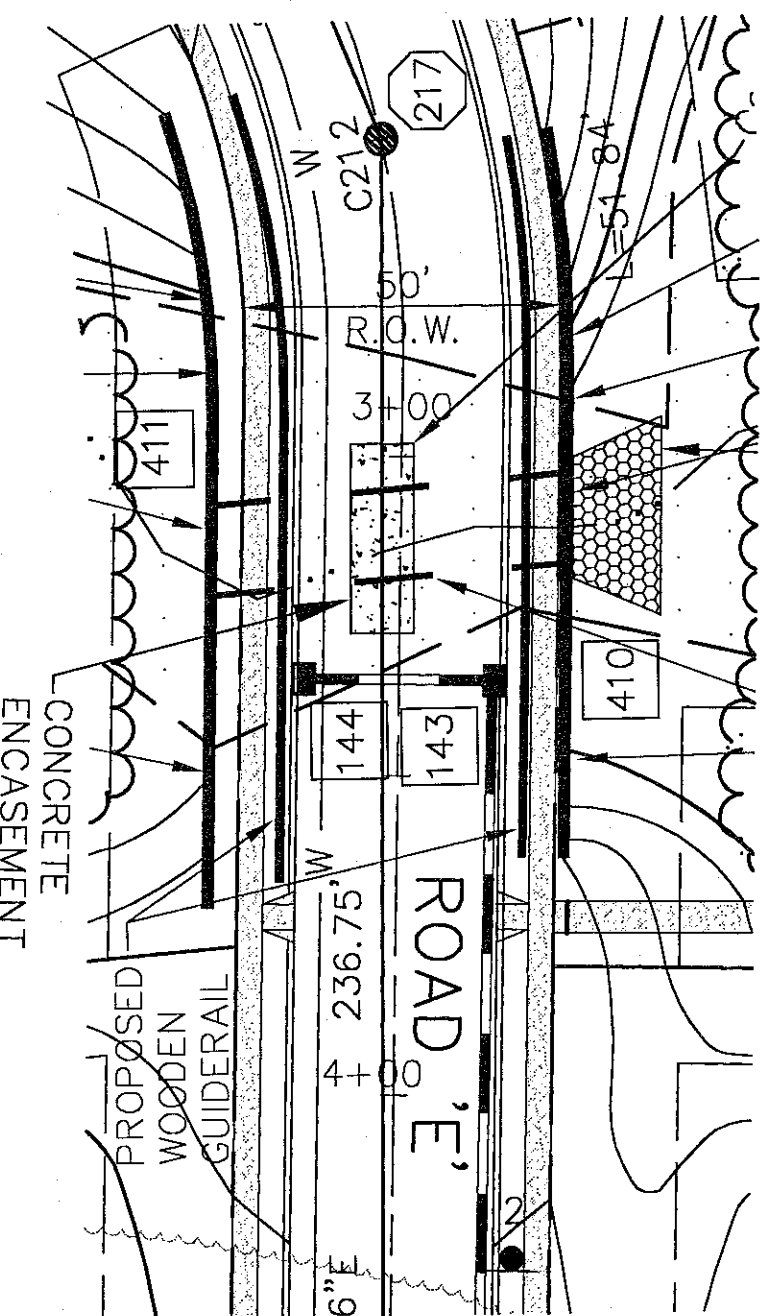

PLAN VIEW: EW #411 TO EW #410

SCALE: 1" = 30'

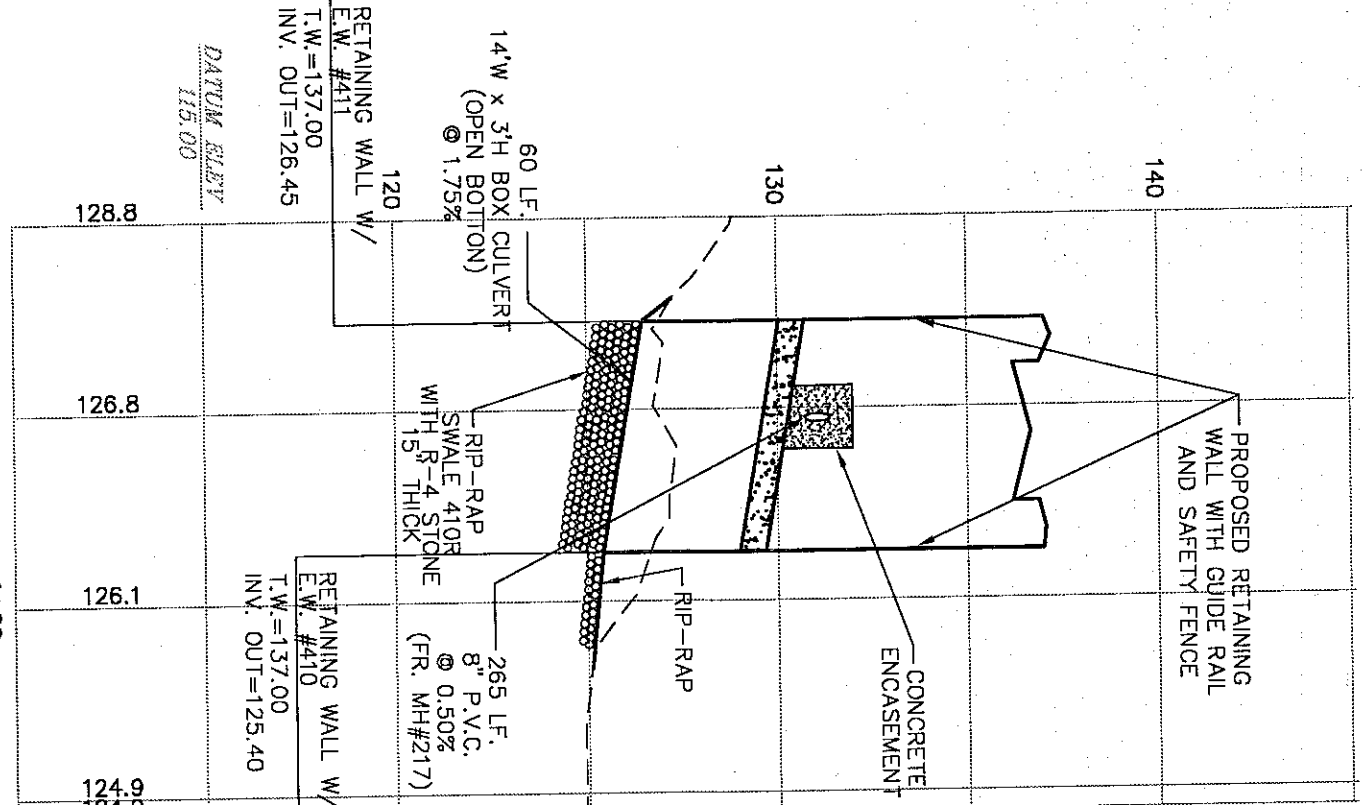

EW #411 TO EW #410

SCALE: 1" = 50' HORIZ.
1" = 5' VERT.

- NOTE:
1. CONTRACTOR TO PROVIDE A MINIMUM OF 1.5' OF CLEARANCE WHERE WATERMAIN CROSSES PROPOSED SANITARY SEWER AND STORM SEWER COLLECTION SYSTEM.
 2. CONTRACTOR TO PROVIDE A MINIMUM OF THREE (3) SANITARY SEWER SERVICE LATERALS, DEEP OUT LATERALS AND LATERAL RISERS TO BE USED WHERE NECESSARY.

ROAD AND UTILITY PLAN & PROFILE
ROAD 'E' STA.1+00 TO STA.5+21.47
REGENCY AT PROVIDENCE
 (a.k.a. FOCEL TRACT)
 UPPER PROVIDENCE TWP, PENNSYLVANIA

DATE: 12/8/03
 DESIGN: JT
 DRAWING: PAB
 JOB NO.: 1114
 FILE NAME: S-PRO-E
 PROJECT: SD07.07
 SHEET: 26 OF 78

REV.	DATE	DESCRIPTION	DRAWN
7	1/31/05	FINAL CONSTRUCTION DRAWINGS	MDD
6	11/22/04	REVIEW LETTER 9/28/04; RDS, A, B, D COMM CIR	MDD
5	8/04/04	AGENCY REVIEW LETTER DATED 7/29/04	MDD
4	8/02/04	PA DEP GENERAL PERMIT REVIEW COMMENTS	JMM
3	7/21/04	PA AMERICAN WATER LETTERS 6/29/2004, 6/30/2004	MDD
2	8/11/04	PA AMERICAN WATER LETTER, DATED 6/9/04	MDD
1	8/07/04	AGENCY REVIEW LETTERS; TOWNSHIP COMMENTS	PAB

ESE EASTERN STATES ENGINEERING
 CIVIL ENGINEERS - LAND SURVEYORS - LANDSCAPE ARCHITECTS - LAND PLANNERS

850 GIBRALTAR ROAD
 SUITE 2E
 HORSHAM, PA 19044
 TEL: (215) 914-2050
 FAX: (215) 293-5488

JAMES D. TAKACS
 REGISTERED PROFESSIONAL ENGINEER
 NO. PERS0046
 PENNSYLVANIA

James Takacs