
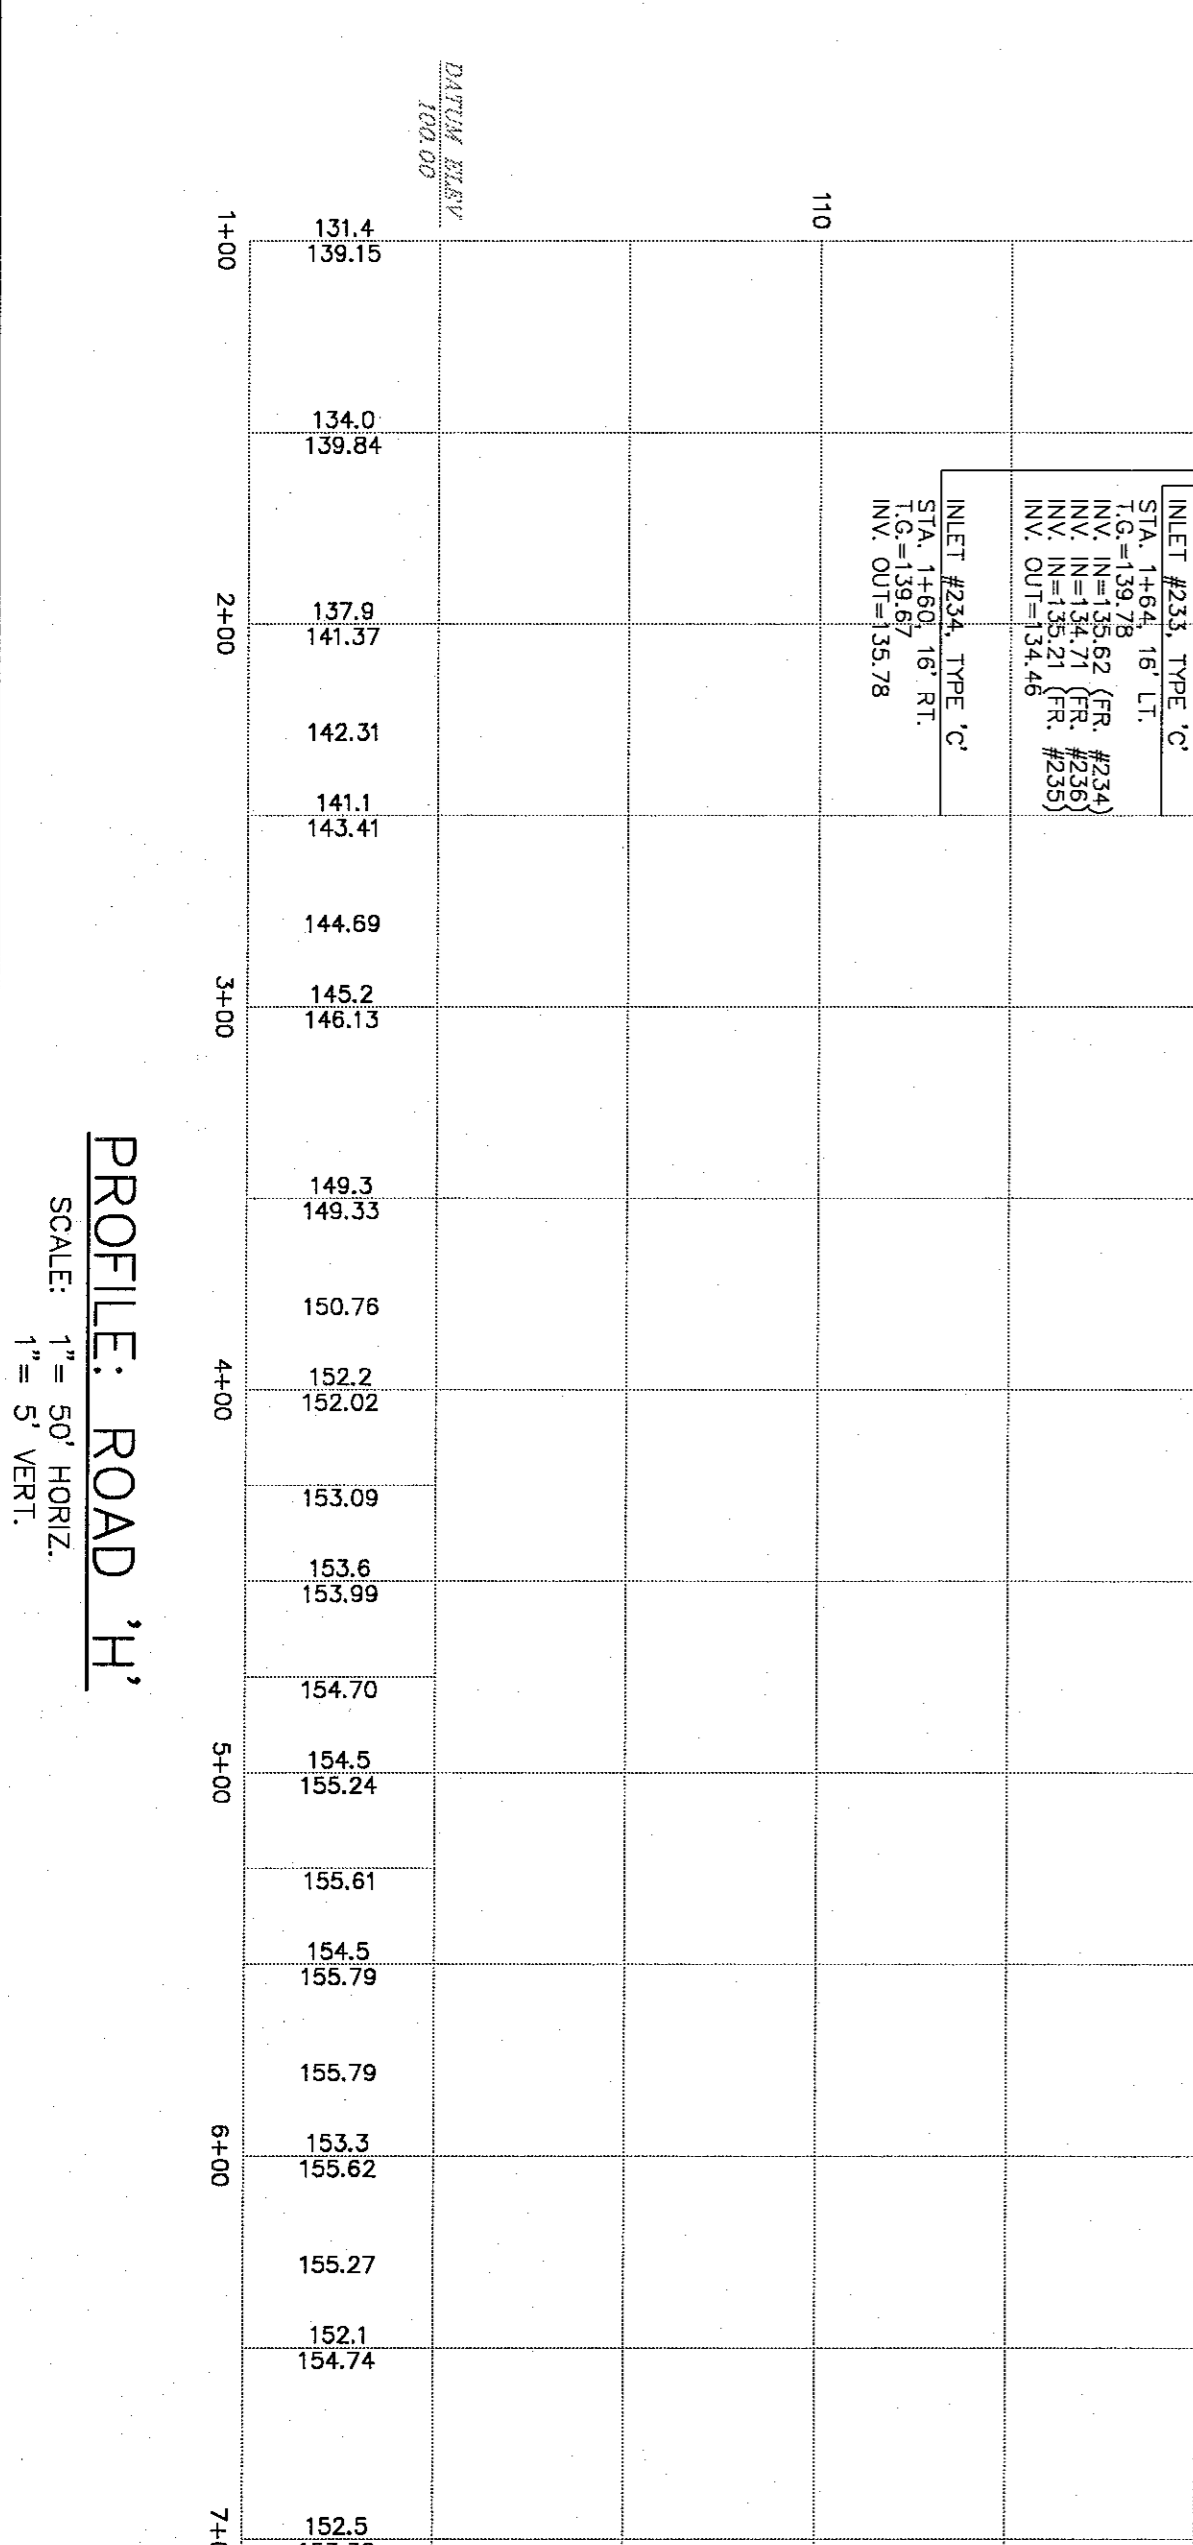


PLAN VIEW: ROAD 'H'  
SCALE: 1" = 50'

CURVE	RADIUS	LENGTH	TANGENT	CHORD	CHORD BEARING	DELTA
C211	150.00'	141.21'	78.33'	138.08'	888°27'46"W	53°56'25"

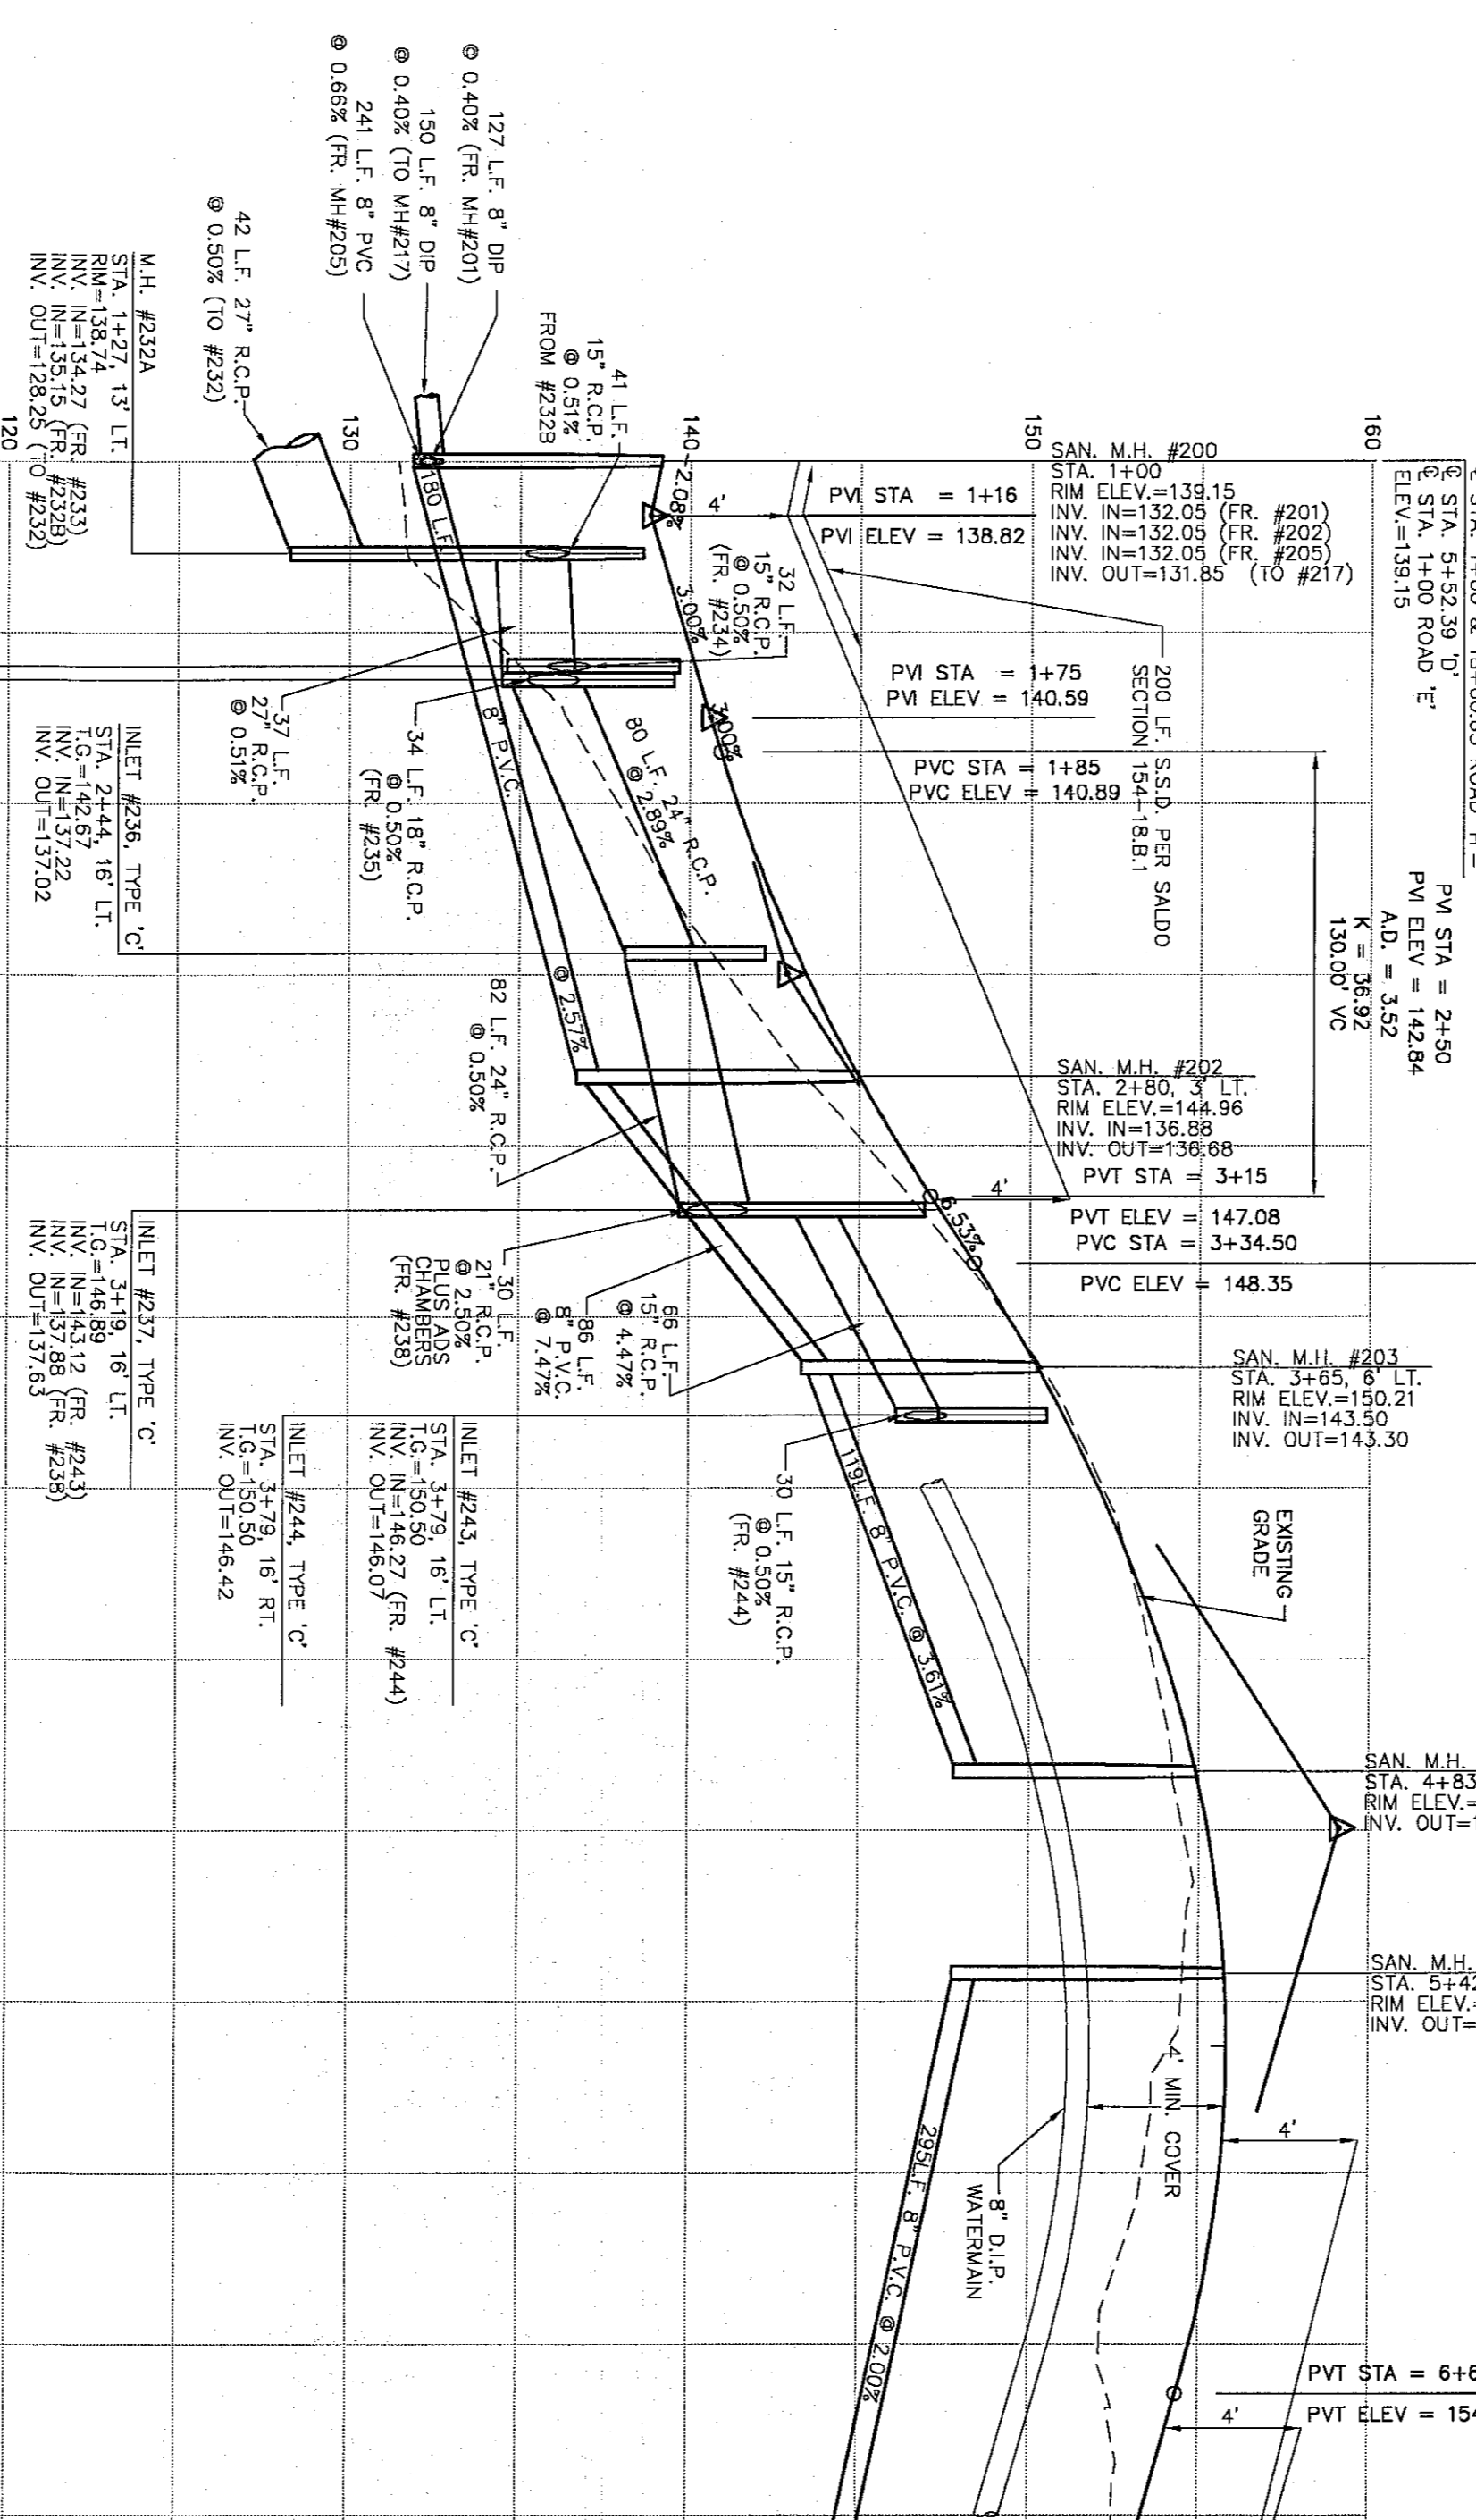

PROFILE: ROAD 'H'  
SCALE: 1" = 50' HORIZ.  
1" = 5' VERT.

NOTE:  
1. CONTRACTOR TO PROVIDE A MINIMUM OF 1.5' OF CLEARANCE WHERE WATERMAIN CROSSES PROPOSED SANITARY SEWER AND STORM SEWER COLLECTION SYSTEM.  
2. CONTRACTOR TO PROVIDE A MINIMUM OF TWELVE (12) INCHES OF CLEARANCE BETWEEN SANITARY SEWER SERVICE LATERALS AND LATERAL RISERS TO BE USED WHERE NECESSARY.

ROAD AND UTILITY PLAN & PROFILE  
ROAD 'H' STA. 1+00 TO STA. 7+00  
**REGENCY AT PROVIDENCE**  
(a.k.a. FOGEL)  
UPPER PROVIDENCE TWP., MONTGOMERY COUNTY, PA

DATE: 12/9/03	SCALE: AS NOTED
DESIGNER: JT	DRAWN: PAB
JOB NO.: 1114	FILE NAME: S-PRO-H-1
REF. NO.: SD07.12	
SHEET NO.: 31	OF 78

REV.	DATE	DESCRIPTION	DRAWN
6	1/31/05	FINAL CONSTRUCTION DRAWINGS	MDD
5	11/22/04	REVIEW LETTER 9/28/04; RDS. A. B. D COMM CTR	MDD
4	8/04/04	AGENCY REVIEW LETTER DATED 7/29/04	MDD
3	7/21/04	AGENCY REVIEW LETTERS 6/29/2004, 6/30/2004	MDD
2	6/11/04	PA AMERICAN WATER LETTER, DATED 6/9/04	MDD
1	6/07/04	AGENCY REVIEW LETTERS: TOWNSHIP COMMENTS	PAB

**ESE EASTERN STATES ENGINEERING**  
250 GIBLALTAR ROAD SUITE 2E  
HORSHAM, PA 19044  
TEL: (215) 914-2050  
FAX: (215) 293-5488

CIVIL ENGINEERS - LAND SURVEYORS - LANDSCAPE ARCHITECTS - LAND PLANNERS

**JAMES D. TAKACS**  
REGISTERED PROFESSIONAL ENGINEER  
No. PESS004  
PENNSYLVANIA